

ELECTRICAL SERVICES • VIC 3463

1 (A)

FLOODLIGHT No. AND DISTRIBUTION TYPE
(SEE DESCRIPTIONS BELOW)

LUMINAIRE AIMING DIRECTION

24m HIGH LIGHT POLE
AND CROSSARM

LP1

LIGHT POLE IDENTIFICATION NUMBER

(A)

NEW 1000W LED FLOODLIGHT (IP66)
WITH NARROW ASYMMETRICAL DISTRIBUTION
C/W REMOTE GEAR, LOCATE IN POLE


LUMINAIRE DETAILS:

"LEGACY INVICTUS GEN II - OPTIC 1"
C/W EXTERNAL DRIVER


NEW HD UPVC UNDERGROUND CONDUIT
(1x 63mm Ø UNLESS OTHERWISE NOMINATED)

P

ELECTRICAL PIT - CATEGORY B

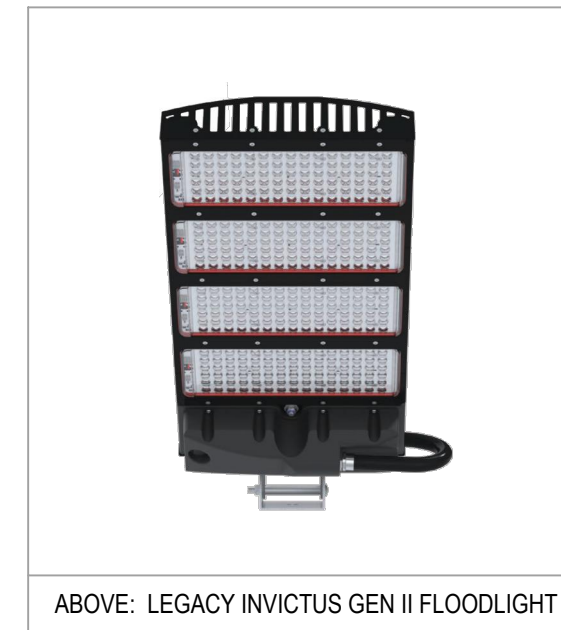

FLOODLIGHT No.	LIGHT POLE No.	LUMINAIRE TYPE	LUMINAIRE TILT ANGLE
1	LP1	(A)	42°
2		(A)	42°
3		(A)	44°
4		(A)	44°
5	LP2	(A)	44°
6		(A)	44°
7		(A)	42°
8		(A)	42°
9	LP3	(A)	44°
10		(A)	44°
11		(A)	45°
12		(A)	45°
13	LP4	(A)	45°
14		(A)	45°
15		(A)	44°
16		(A)	44°

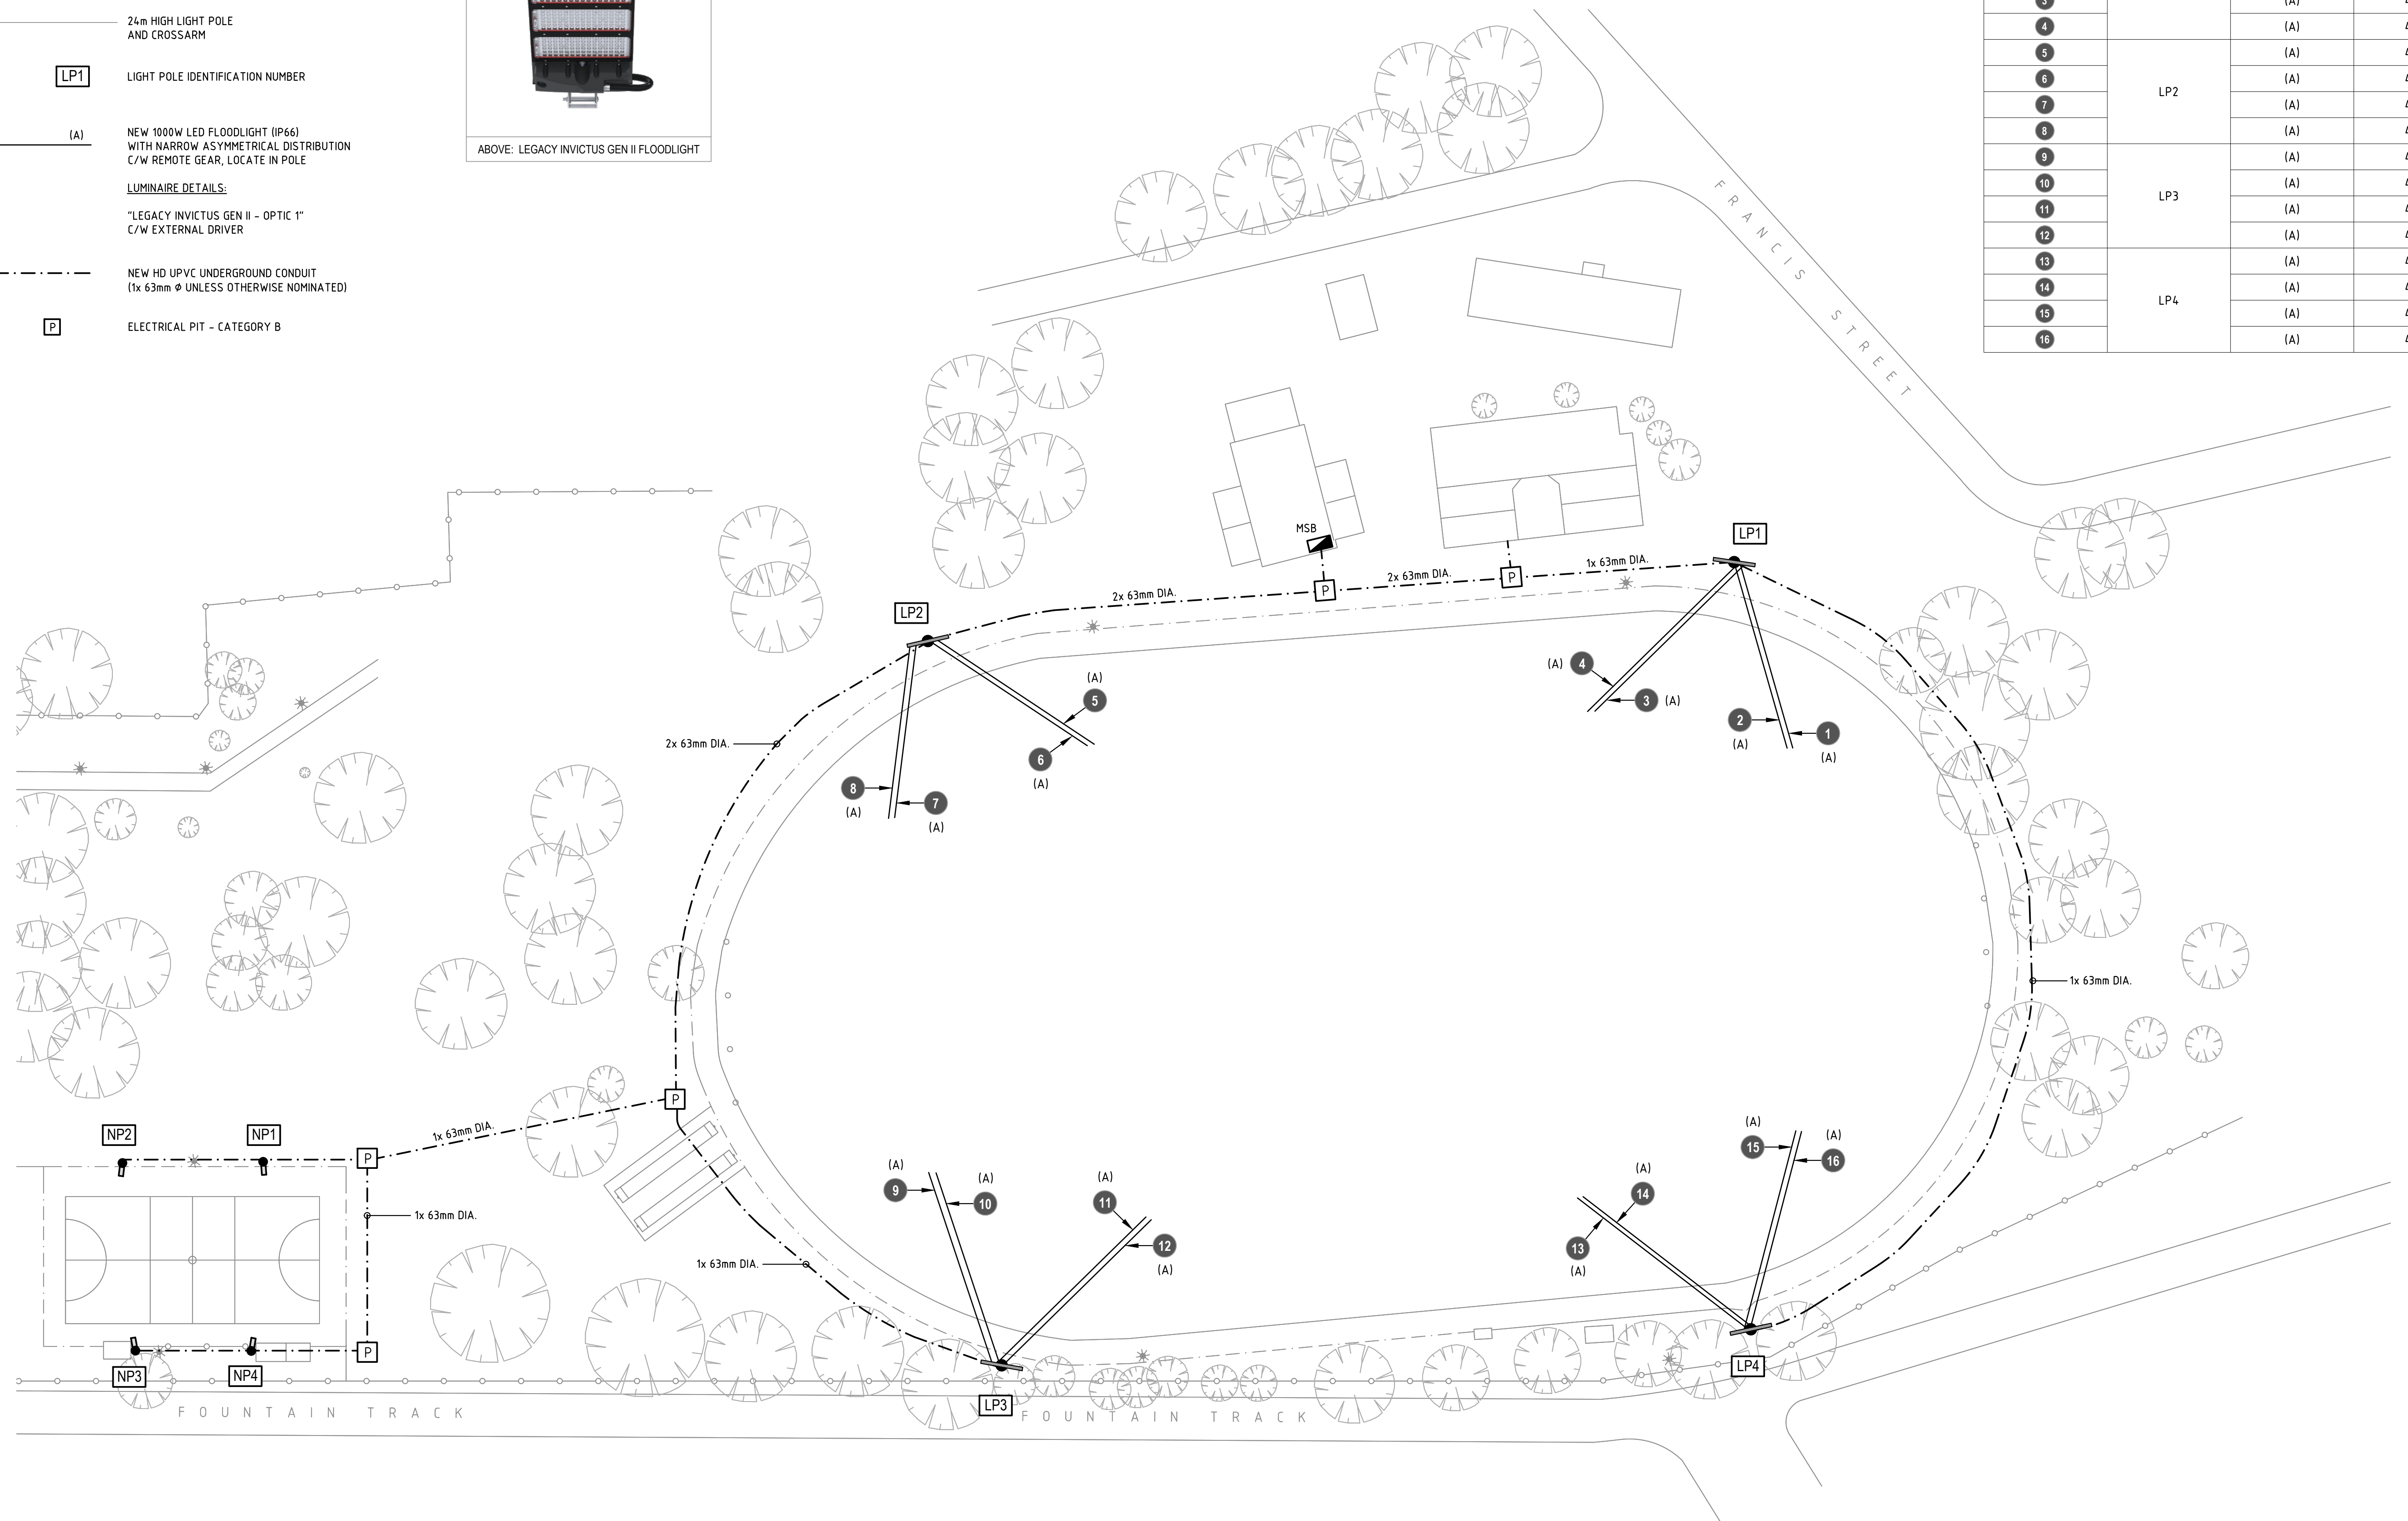

REVISION		DATE	REV	APP	REVISION	DATE	REV	APP	CONSULTING ELECTRICAL ENGINEERS LIGHTING CONSULTANTS TECHNOLOGY CONSULTANTS			CLIENT	PROJECT DETAILS		DRAWING	 SCALE 1:400 @ A1	JOB No.	DRAWING No.	D	R	A	
01	CONCEPT	27.07.22	P.M.	R.H.					WEBB AUSTRALIA GROUP (VIC) PTY LIMITED ACN 61 073 585 305 LEVEL 9, 128 EXHIBITION STREET MELBOURNE VIC 3000 AUSTRALIA TELEPHONE 03 9552 0333 FACSIMILE 03 9552 0300 EMAIL melbourne@webbaustralia.com.au				BILL WOODFULL RECREATION RESERVE	FOOTBALL OVAL LIGHTING PLAN 4 POLE SOLUTION			P312B	E-301	A.P.	P.M.	R.H.	
									COPYRIGHT © WEBB AUSTRALIA GROUP (VIC) PTY LTD ACN 61 073 585 305. ALL RIGHTS RESERVED. THIS DRAWING MAY NOT BE REPRODUCED OR TRANSMITTED IN ANY FORM OR BY ANY MEANS IN PART OR IN WHOLE WITHOUT THE WRITTEN PERMISSION OF WEBB AUSTRALIA GROUP (VIC) PTY LTD. WEBB AUSTRALIA GROUP DRAWINGS ARE SCHEMATIC AND SHALL BE READ IN CONJUNCTION WITH ALL CONTRACT DOCUMENTATION. SHOULD ANY AMBIGUITY, ERROR, OMISSION, INEPPORANCY, INCONSISTENCY OR OTHER FAULT APPEAR TO EXIST IN THE DOCUMENTS, IMMEDIATELY NOTIFY THE CONTRACT ADMINISTRATOR IN WRITING.									STATUS		REV		
																		CONCEPT				01